



1 / M-A2056 CONFERENCE ROOM - EQUIPMENT PLAN VIEW

Scale: $\frac{3}{8}'' = 1'-0''$

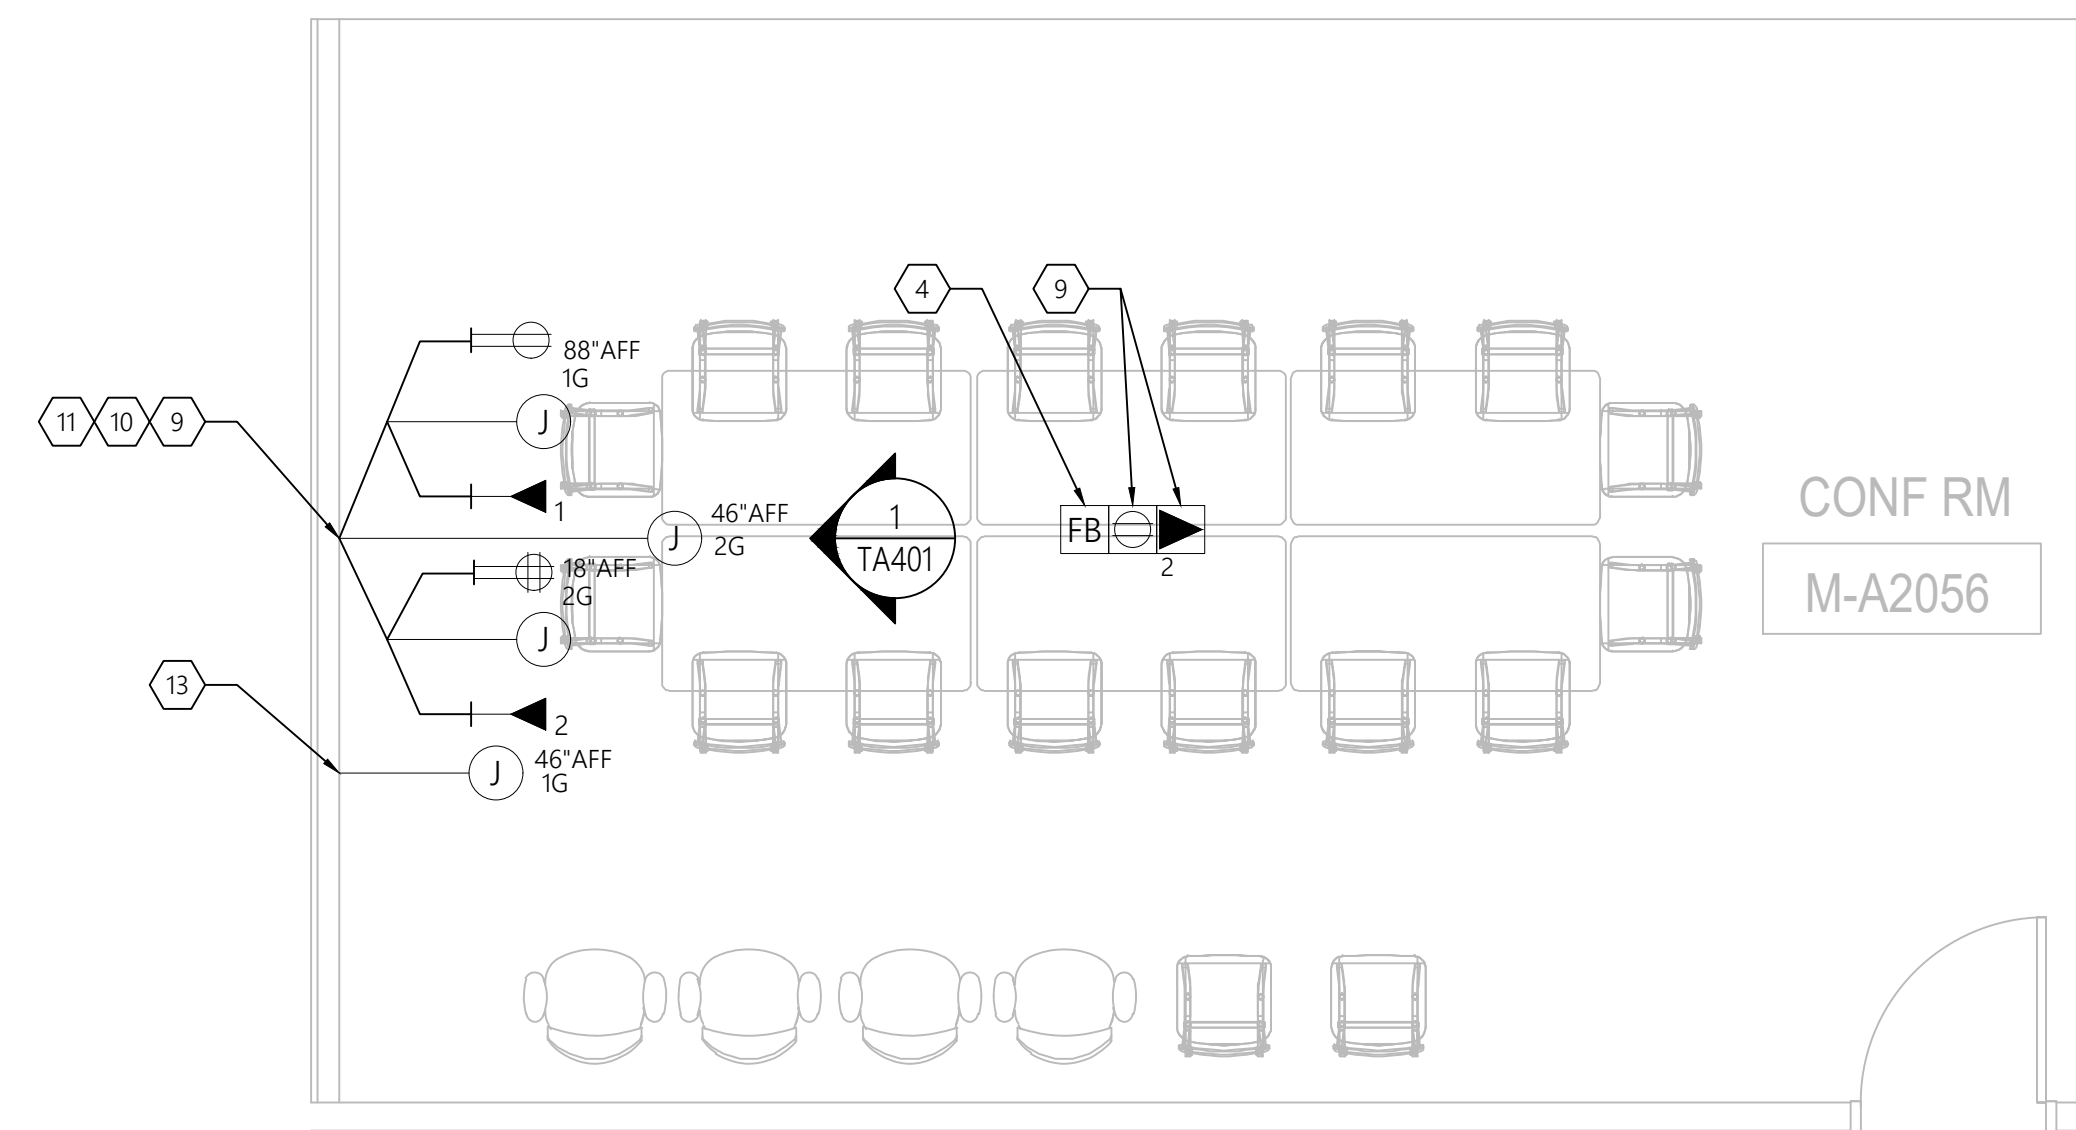


3 / M-A2056 CONFERENCE ROOM - ELECTRICAL PLAN VIEW

Scale: $3/8" = 1'-0"$

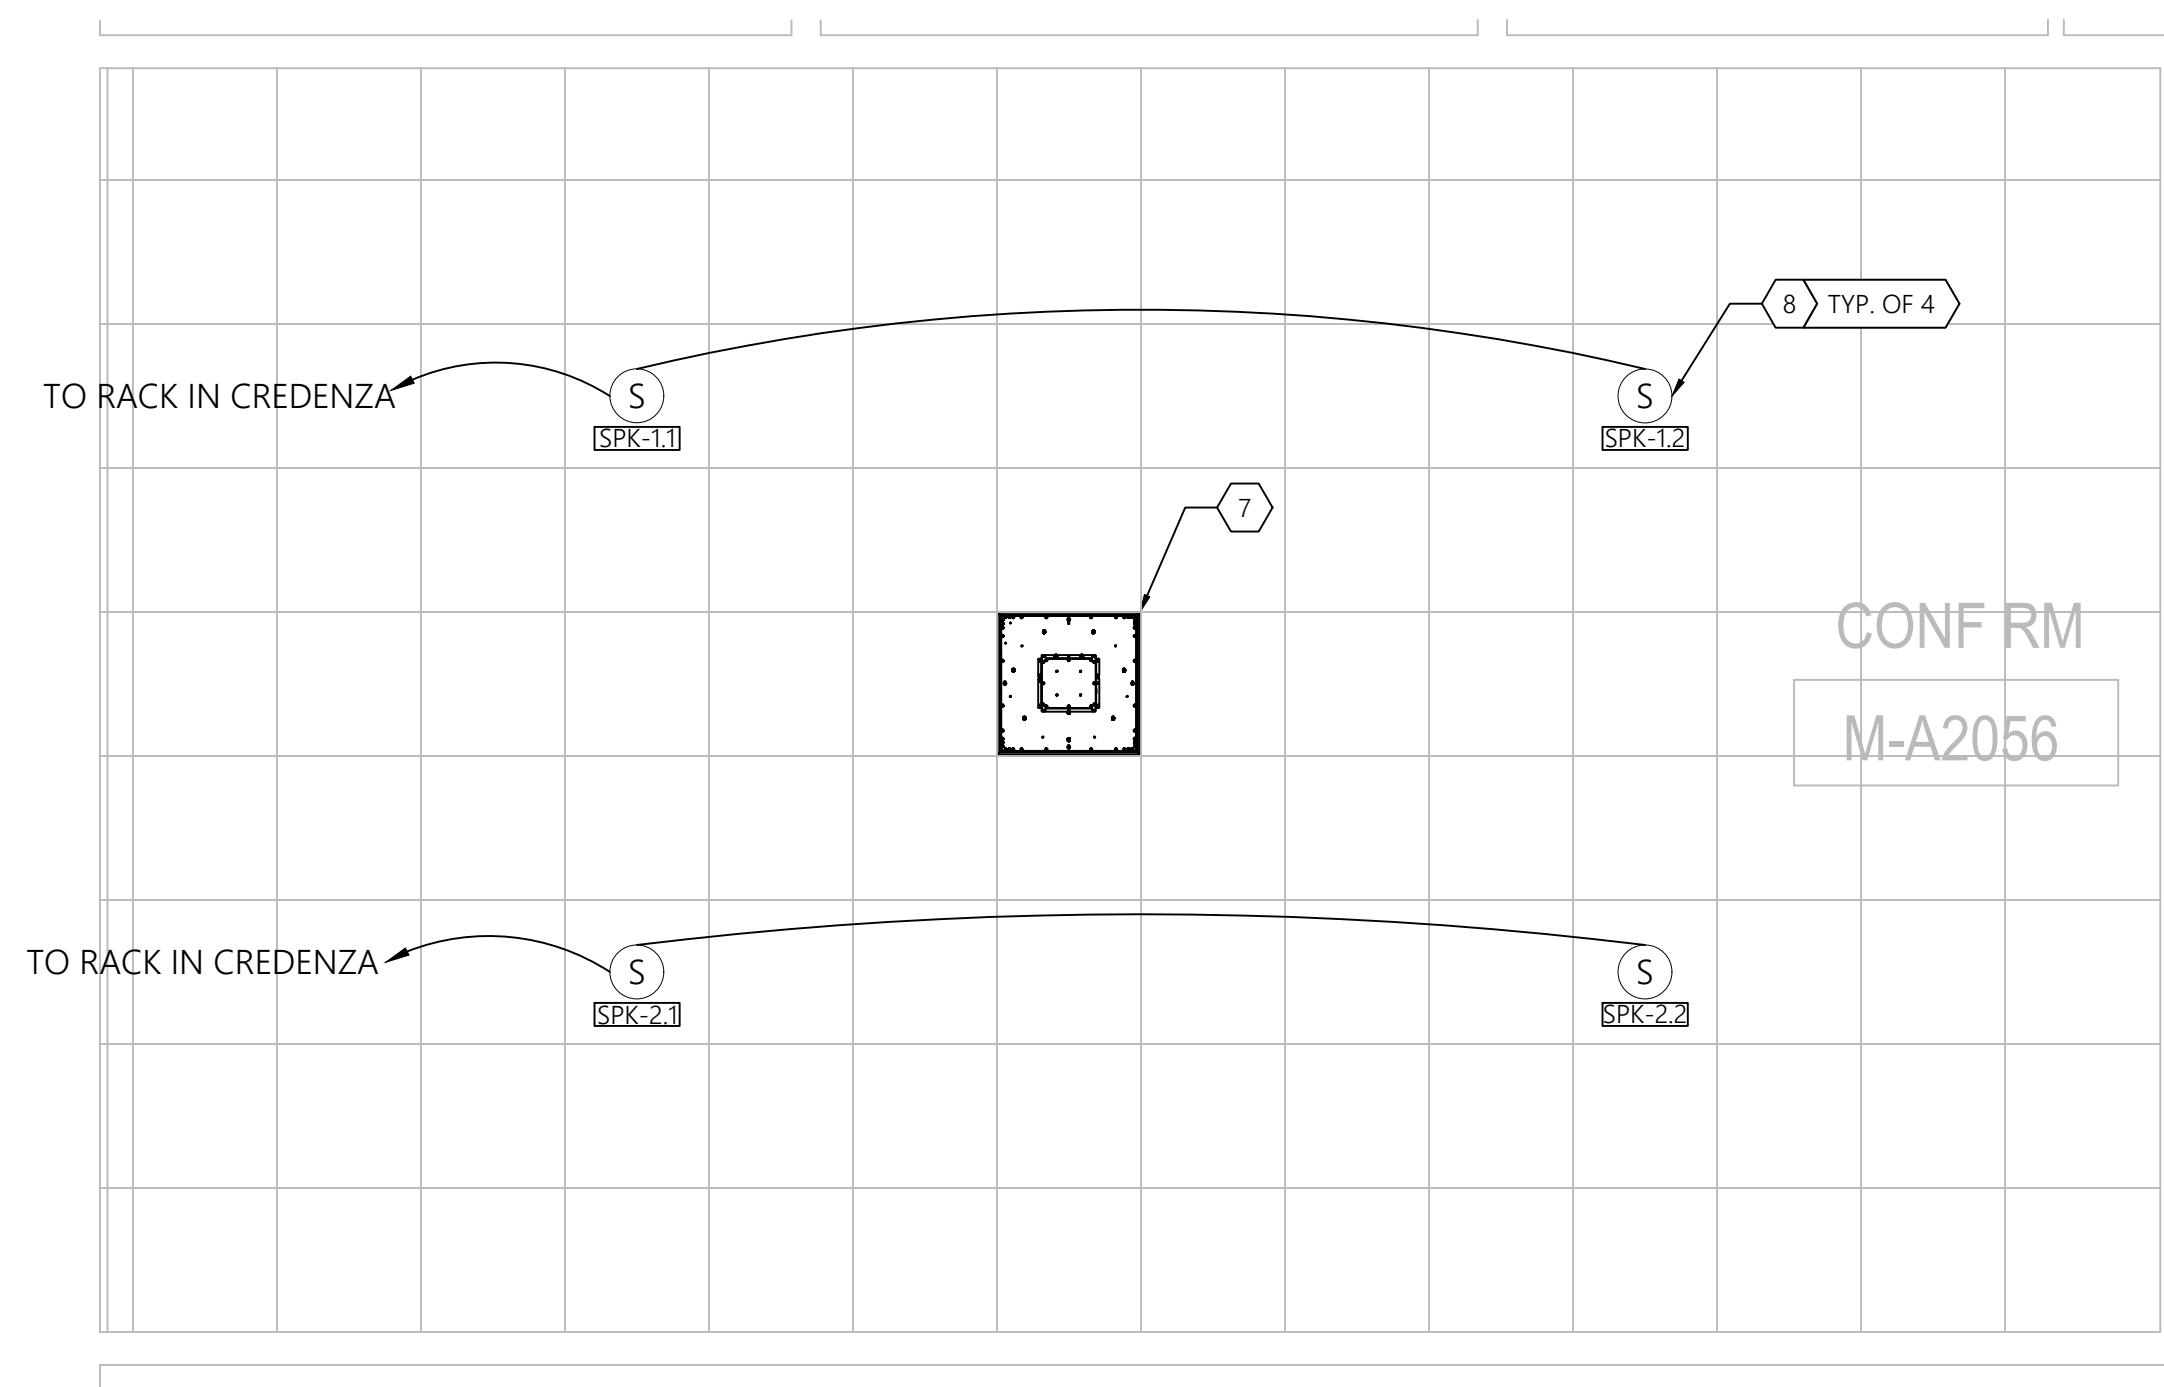

3 / M-A2056 CONFERENCE ROOM - EQUIPMENT RCP VIEW

Scale: 3/8" = 1'-0"

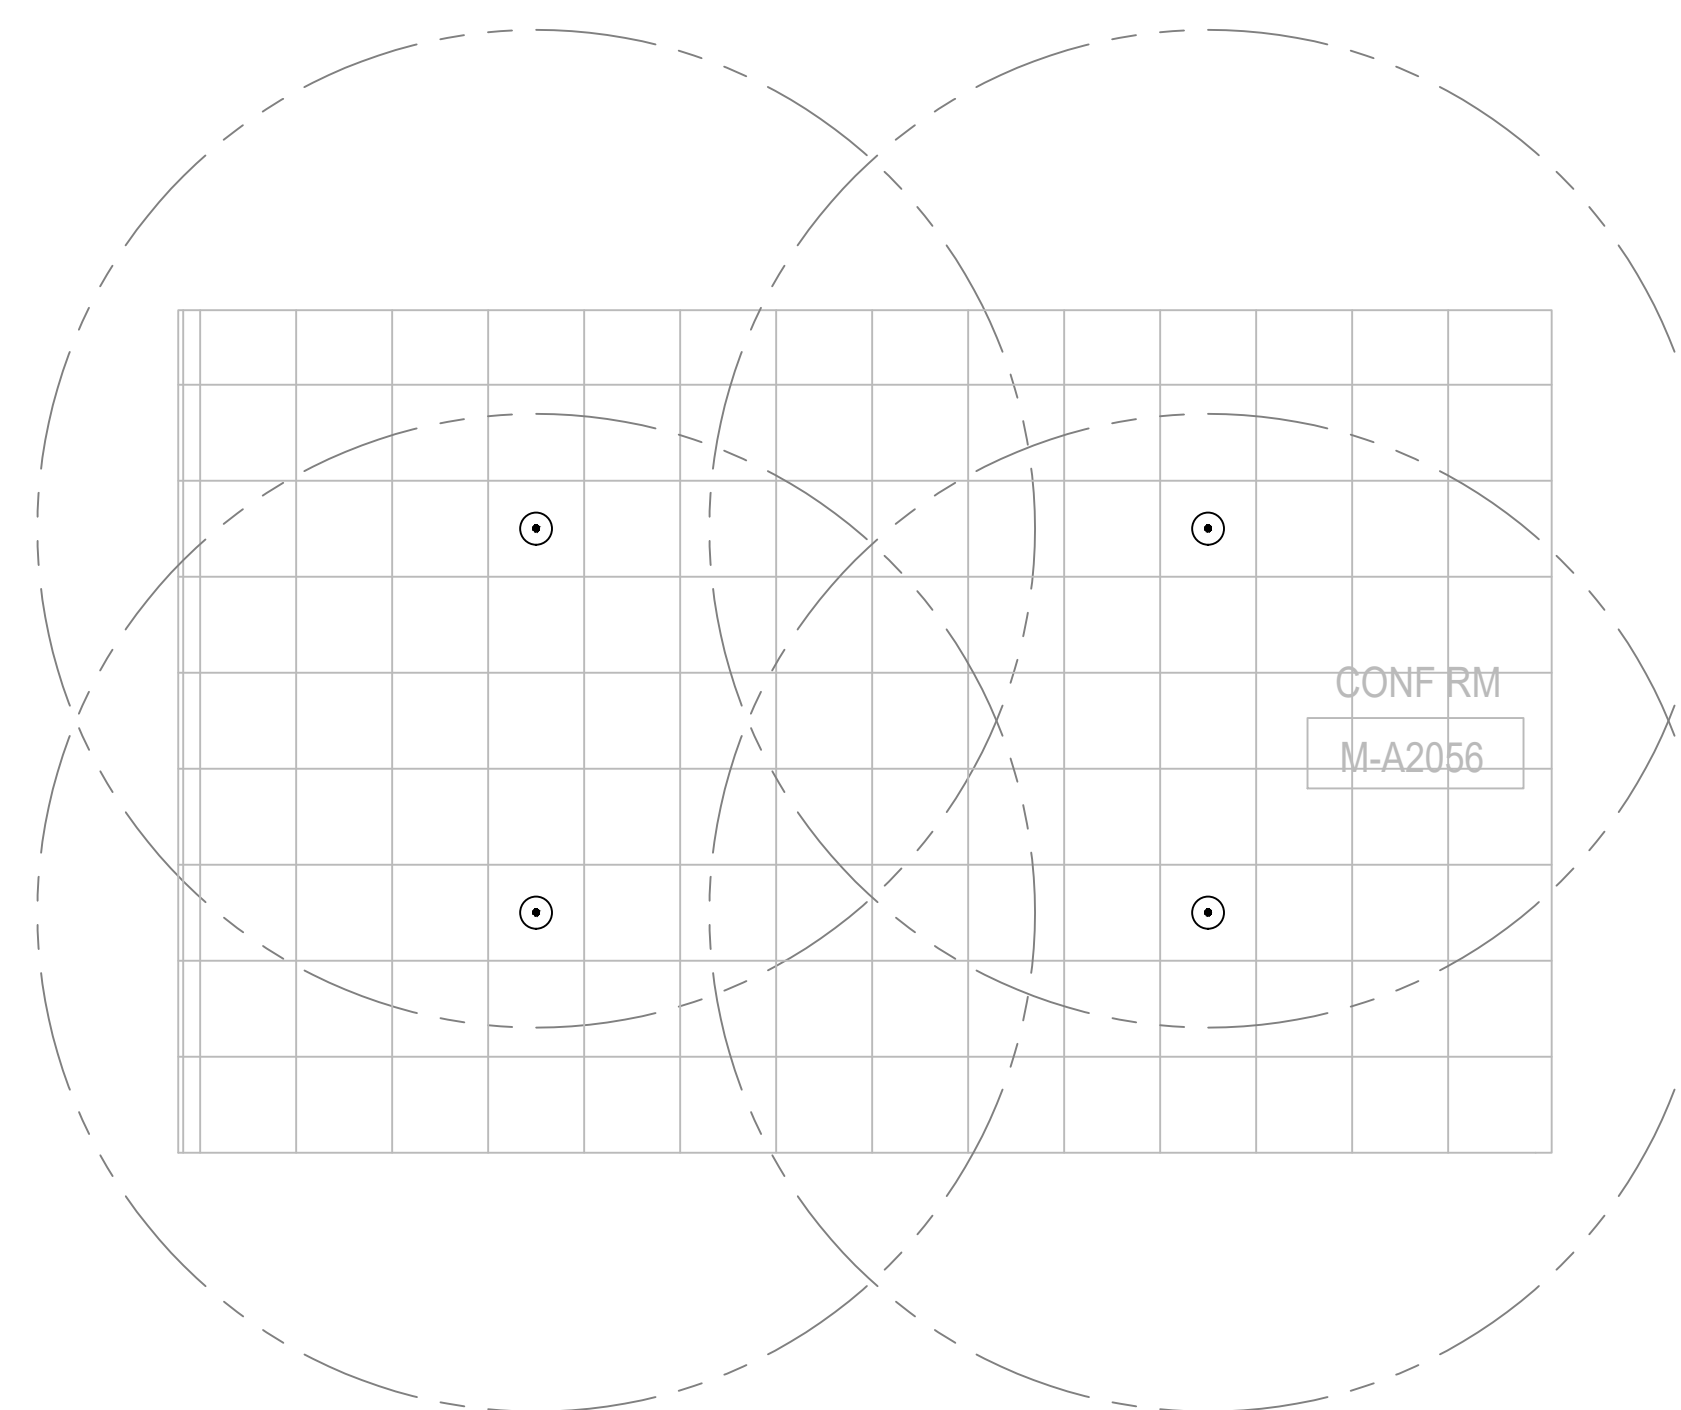

4 / M-A2056 CONFERENCE ROOM - SPEAKER PATTERN

Scale: 1/4" = 1'-0"

GENERAL NOTES

- A. ROOM LAYOUTS ARE TYPICAL AND ARE FOR REFERENCE ONLY. REFER TO ARCHITECTURAL PLANS FOR EXACT ROOM LAYOUTS
- B. ALL POWER, DATA TO BE PROVIDED BY OTHERS.
- C. THE AV SYSTEM SHOULD RECEIVE A SINGLE PHASE FEED THAT IS PROPERLY GROUNDED.
- D. ALL CIRCUITS TO BE 20A. VOLTAGE DICTATED BY REGION.

SHEET KEYNOTES

1. SAMSUNG QB85R 85" COMMERCIAL DISPLAY.
2. PEERLESS-AV PA762 WALL MOUNT.
3. AVER COM520PR2 CONFERENCE CAMERA WITH INCLUDED WALL MOUNT.
4. EC/OWNER PROVIDED POKE THRU OR FLOOR BOX WITH 1" CONDUIT CONNECTED TO J-BOX BEHIND CREDENZA.
5. CRESTRON TS-1070-B-S TABLETOP TOUCH SCREEN.
6. CRESTRON HD-TX-101-C-E TRANSMITTER MOUNTED UNDER TABLE.
7. SHURE MXA920W-US CEILING ARRAY MICROPHONE.
8. SONANCE PS-C63RT CEILING SPEAKER.
9. POWER & DATA PROVIDED BY OTHERS.
10. 1-GANG J-BOX WITH 1-1/4" CONDUIT STUBBED TO ACCESSIBLE SPACE.
11. 2-GANG J-BOX WITH 1-1/4" CONDUIT CONNECTED TO J-BOX ABOVE.
12. EXTRON CABLE CUBBY 500.
13. 1-GANG J-BOX WITH 1" CONDUIT.
14. CRESTRON USB-EXT2-REMOTE-1G-W WALL PLATE.
15. LEGRAND C5 FF27-3 CREDENZA.



955 E. Javelina Avenue
Mesa, Arizona 85204
T: 480.892.1071
F: 480.892.5295
www.L3AV.com



CLIENT:

MERCY GILBERT PATIENT
TOWER

PROJECT NAME:

3555 S VAL VISTA DRIVE
GILBERT
AZ 85297

SITE ADDRESS:

[illegible]

ISSUED FOR:

PROJECT NO.:	5966
--------------	------

SCALE: $3/8"=1'$

DRAWN BY: R. MOORE

APPROVED BY: M. FOGNANI

BUILDING:

FLOOR:

ROOM: M-A2056

AV PLAN VIEWS, RCP VIEWS AND SPEAKER PATTERN

SHEET TITLE

TA201.1

SHEET NUMBER: